


Exh. Petitioner EJM-2

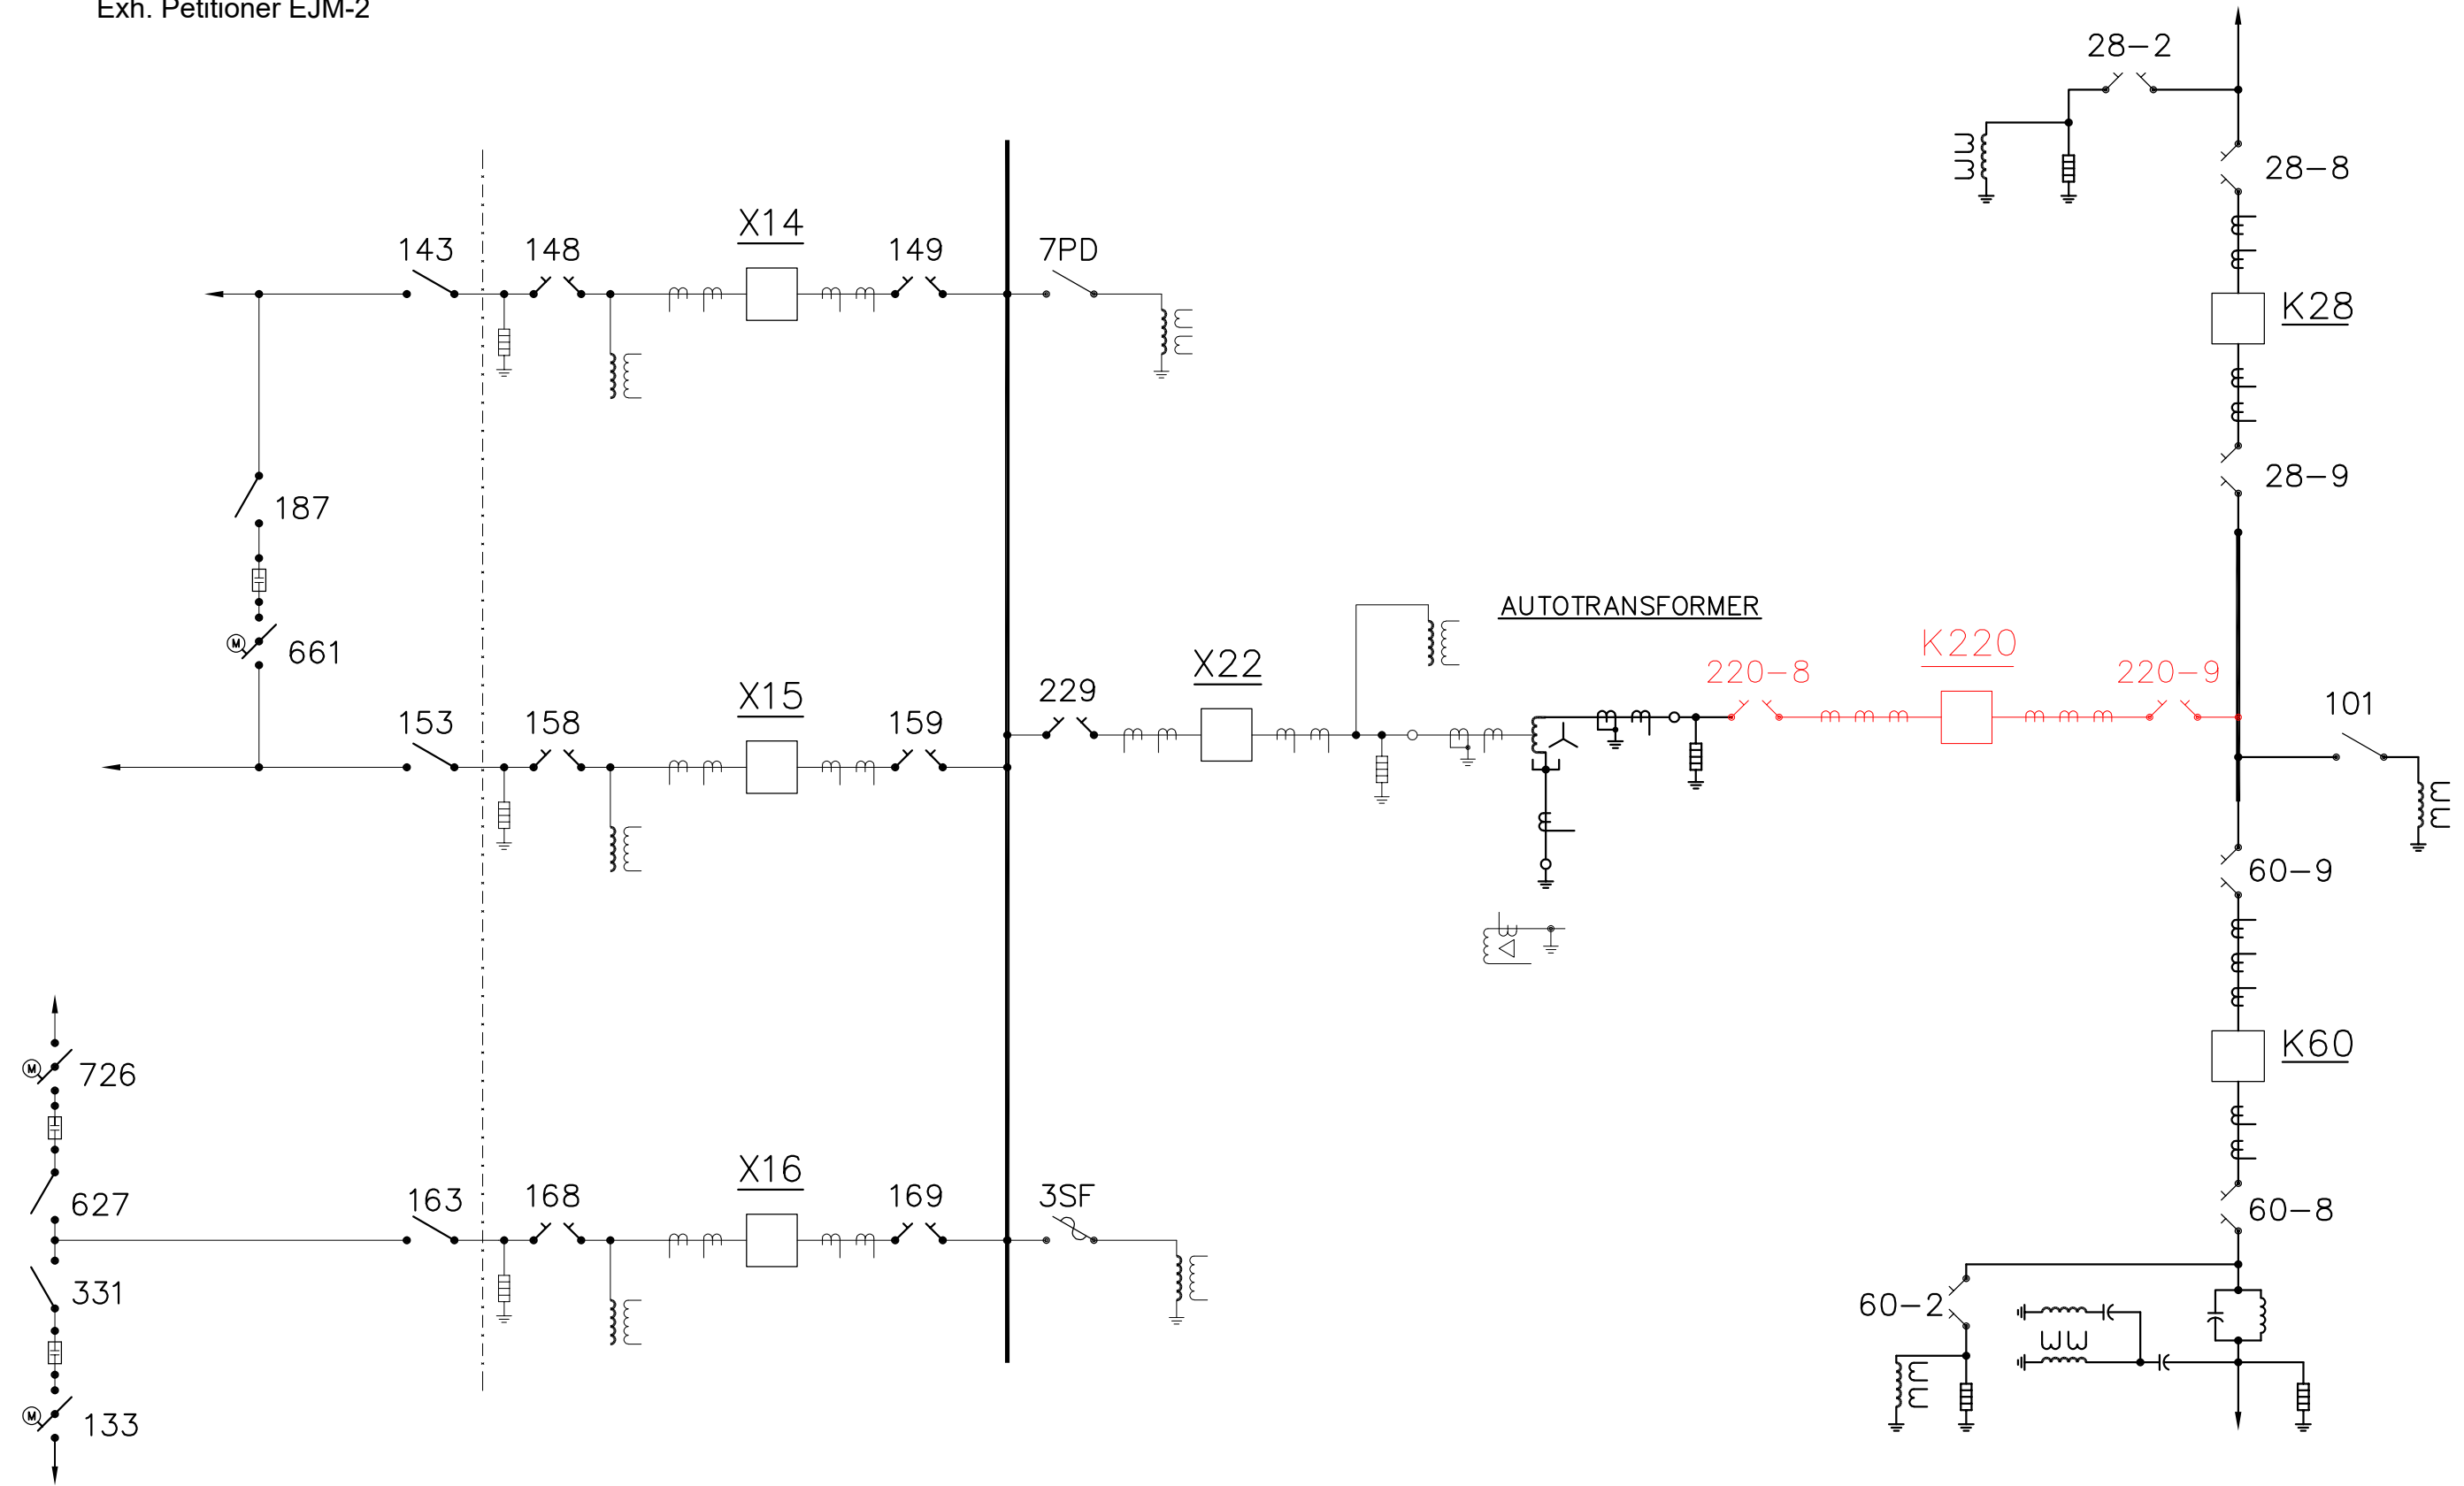

0	10.07.23	AG	EJM	ISSUED FOR PERMIT
REV	DATE	DR	CK	DESCRIPTION
VELCO				VERMONT ELECTRIC POWER CO., INC. RUTLAND, VERMONT
ST. JOHNSBURY SUBSTATION				
ST. JOHNSBURY SUBSTATION ONE LINE DIAGRAM				
SCALE: NONE	DRAWN BY: AG	APPROVED BY:		DATE
DATE: 06.22.23	CHECKED BY: EJM	EJM		0
DRAWING NUMBER:	227-OL-0002D			REV:
PLOT: 1=1				