


Exhibit Petitioner EJM-2

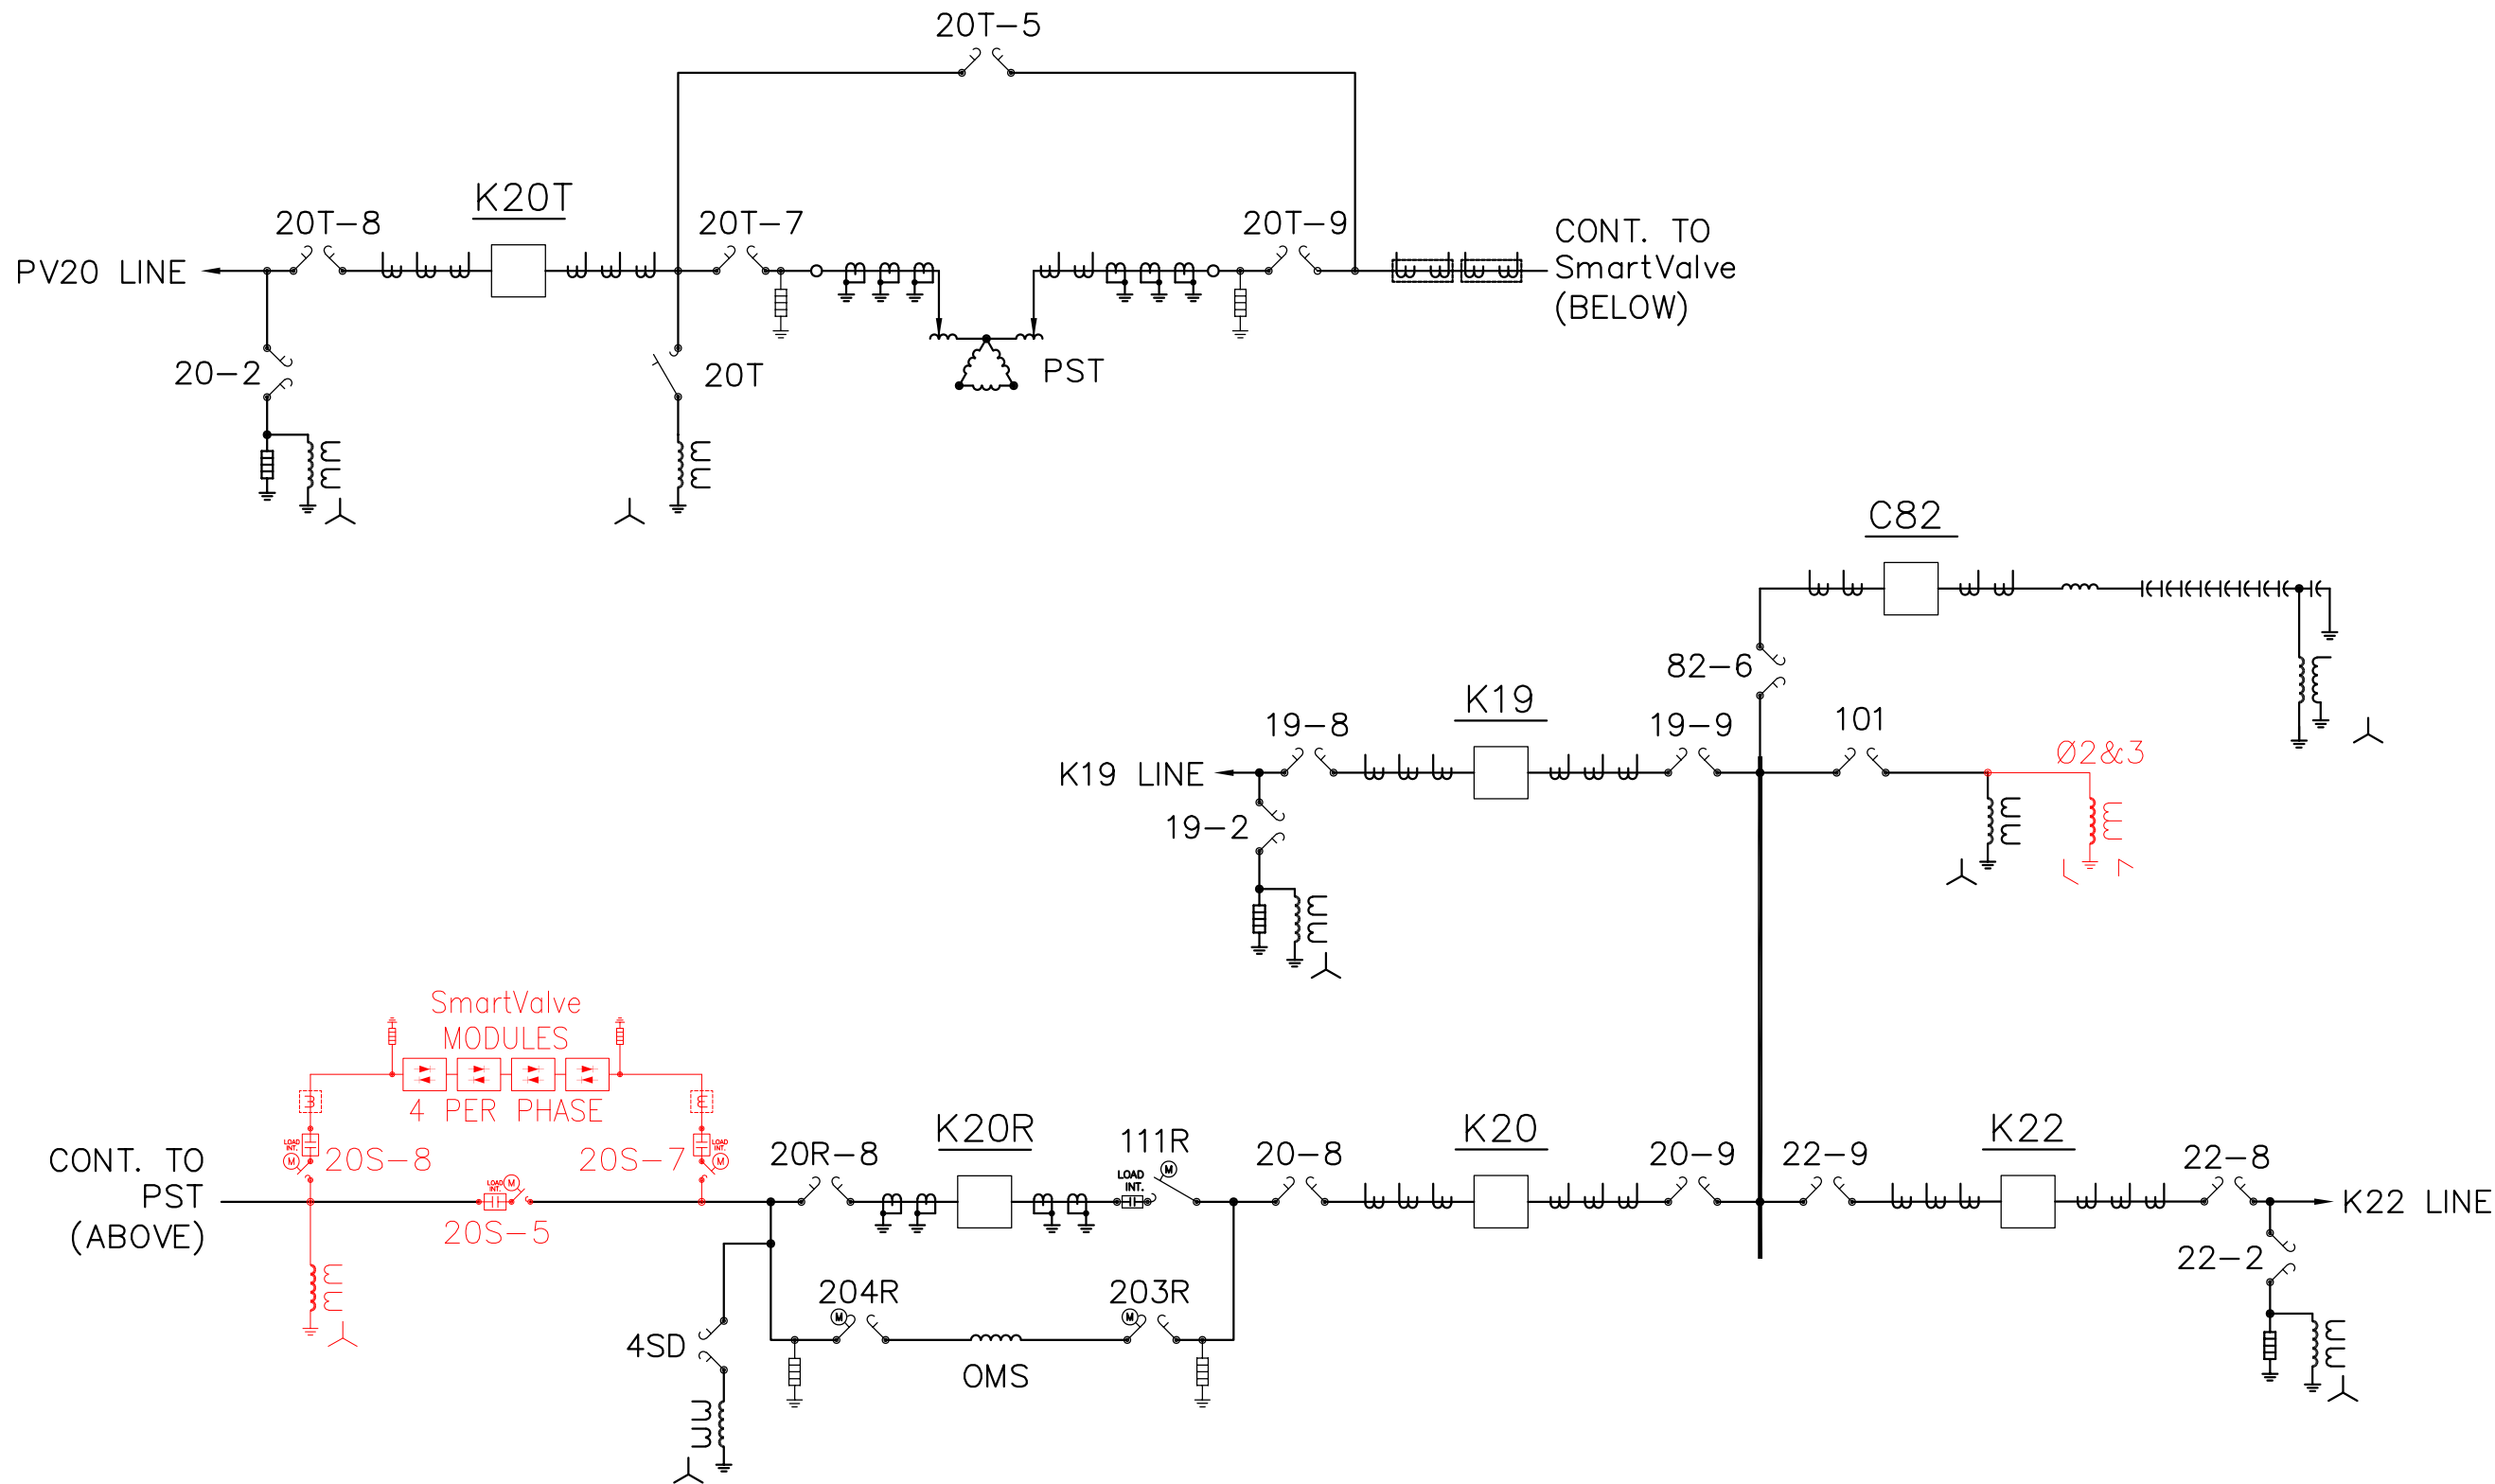

NOTES:
1. * - ...

0	06.08.20	JJC	EJM	ISSUED FOR FILING
REV	DATE	DR	CK	DESCRIPTION
VELCO VERMONT ELECTRIC POWER CO., INC. RUTLAND, VERMONT				
SANDBAR SWITCHING STATION				
SANDBAR STATION ONE LINE DIAGRAM				
SCALE: NONE	DRAWN BY: AG	APPROVED BY:		
DATE: 10.29.20	CHECKED BY: FJH	EJM	DATE	
DRAWING NUMBER:	236-OL-0002D		0	
PLOT: 1=1			REV.	

FILE: F:\236\2360002D